

FOR CONTINUATION SEE MKS-MET-ZZ-ZZ-DR-E-6001B

This drawing is the copyright of METEC Consulting Engineers and may not be reproduced in whole or in part without their expressed written permission. All figures and dimensions are to be verified on site and any discrepancy is to be reported to the Engineer immediately.



LEGEND OF SYMBOLS


- 1 TYPE 1 - KREOS SR/150 PERFORMANCE LIGHTING
- 2 TYPE 2 - DUO LUNA (1 MOD/M) (KROCC)
- 3 TYPE 3 - HEDO+FT SR/075 PERFORMANCE LIGHTING
- 4 TYPE 4 - KREOS SR/100 PERFORMANCE LIGHTING
- 5 TYPE 5 - HWY SUPER-COMFORT (GUZZINI)
- 6 TYPE 6 - WALKY SQUARE (GUZZINI)
- 7 TYPE 7 - HEDO+FT PERFORMANCE LIGHTING
- 8 TYPE 8 - PALCO IN/OUT (GUZZINI)
- 9 TYPE 9 - LIGHT UP EARTH (GUZZINI)
- 10 TYPE 9 - HWY SUPER-COMFORT (GUZZINI)
- 11 TYPE 11 - ATON PFB ALDABRA
- 12 1 LUX LIGHTING SOUNDS - INDICATES BOUNDARY LUX LEVELS



TYPE 1 KREOS SR/150 (PERFORMANCE LIGHTING) MOUNTED ON TIMBERLAB PILA POLE
 TYPE 2 DUO LUNA (1 MOD/M) (KROCC)
 TYPE 3 HEDO+FT SR/075 (PERFORMANCE LIGHTING) MOUNTED ON TIMBERLAB PILA POLE
 TYPE 4 KREOS SR/100 (PERFORMANCE LIGHTING) MOUNTED ON TIMBERLAB PILA POLE



TYPE 5 HWY SUPER-COMFORT (GUZZINI) INTEGRATED INTO TIMBERLAB PIATTO
 TYPE 6 WALKY SQUARE (GUZZINI)
 TYPE 7 HEDO+FT (PERFORMANCE LIGHTING) MOUNTED ON TIMBERLAB PILA POLE
 TYPE 8 PALCO IN/OUT (GUZZINI)
 TYPE 9 LIGHT UP EARTH (GUZZINI)

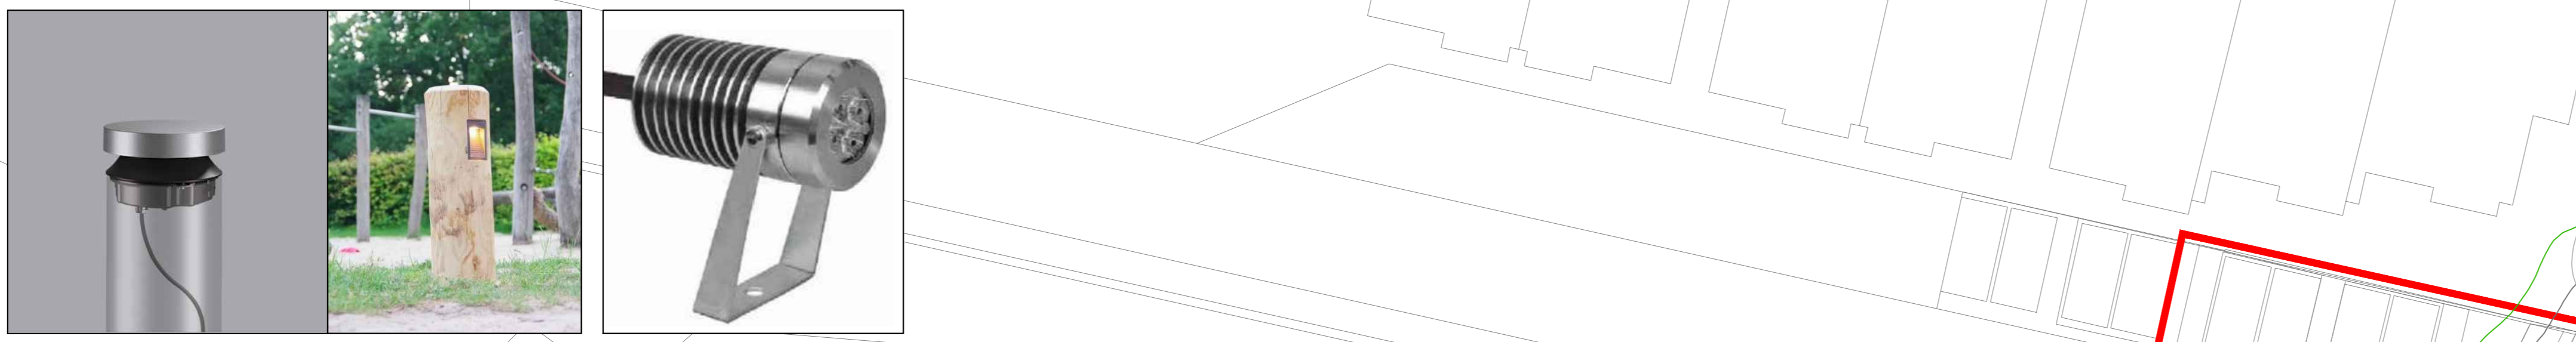

TYPE 10 HWY SUPER-COMFORT (GUZZINI) INTEGRATED INTO TIMBERLAB PIATTO
 TYPE 11 ATON PFB (ALDABRA)

LUMINAIRE LIST (SITE 1)									
INDEX	MANUFACTURER	ARTICLE NAME	ITEM NUMBER	FITTING	LUMINOUS FLUX	MAINTENANCE FACTOR	CONNECTED LOAD	QUANTITY	
1	PERFORMANCE IN LIGHTING	KREOS SR/150 34W 720 AN-V6 RPA	3106268	1x KREOS SR/150 34W 720	3764 lm	0.67	34 W	10	
2	NOT YET A DALI-X MEMBER	DUO LUNA 3000K (1 MODULE PER M) 12V DC	DUO LUNA 3000K (1 MODULE PER M) 12V DC	1x LED	35 lm	0.67	0.5 W	780	
3	PERFORMANCE IN LIGHTING	HEDO+ FT 14W 740 SR/075 NEMA - ANTHRACITE GREY	3106066	1x LED	1697 lm	0.67	14 W	26	
4	PERFORMANCE IN LIGHTING	KREOS SR/100 16W 720 AN-V6 DALI NEMA SOCKET	3106154	1x KREOS SR/100 16W 720	2099 lm	0.67	16 W	19	
5	GUZZINI	HWY SUPER-COMFORT - ROUND - LEUCHTENDRUSE Ø180MM - LED WARM WHITE - 220-240VAC DALI - OPTIK 180° SUPER-COMFORT - FULL CUT-OFF 12.2M	EP04-15_EP17-15_B513-00	1x LED	1650 lm	0.67	12.3 W	62	
6	GUZZINI	WALKY - SQUARE - E03.15 - SQUARE OPTIC ASSEMBLY 180° BOWEN AL OPTIC - WARM WHITE LED - 220-240VAC - 9.3W 1500LM - 3000K - GREY	E032-15_K338-15	1x LED	1500 lm	0.67	11.5 W	15	
7	PERFORMANCE IN LIGHTING	HEDO+ FT 18W 740 C/EM NEMA - ANTHRACITE GREY	3106062	1x LED	2185 lm	0.67	18 W	8	
8	GUZZINI	PALCO IN/OUT - Ø83MM - STRALER MIT ANSCHLUSSDOSE - LED WARM WHITE - ENKABELTE ELEKTROISCHE VERSORGUNGSEINHEIT - MIDIM-OPTIK 10.9M	EP01-01_K253-04_K245-01	1x LED	950 lm	0.67	10.9 W	7	
9	GUZZINI	LIGHT UP EARTH - FLUSH FRAME - ER44.13 - RECESSED LUMINAIRE EARTH Ø=289 MM - FLUSH-MOUNT STAINLESS STEEL FRAME - WARM WHITE - OPTIK OPTIC - DALI - 12W 1500LM - 3000K - STEEL	ER44-13_K488-04	1x LED	1850 lm	0.67	14.5 W	7	
10	GUZZINI	HWY SUPER-COMFORT - ROUND - LEUCHTENDRUSE Ø180MM - LED WARM WHITE - 220-240VAC DALI - OPTIK 300° SUPER-COMFORT 13.1M	EN07-15_EP17-15_B513-00	1x LED	2000 lm	0.67	13.1 W	2	
11	NOT YET A DALI-X MEMBER	ATON 3x 24V 10' 4000K	ATO.03.M4000.0	1x ATO.03.M4000.0	342 lm	0.67	5 W	10	



FOR CONTINUATION SEE MKS-MET-ZZ-ZZ-DR-E-6001B

NOV '22	PLANNING ISSUE
NOV '22	DESCRIPTION

metec
 CONSULTING ENGINEERS
 mechanical • electrical • energy

client: DALGUISE MONKSTOWN



PROJECT: SITE LIGHTING LAYOUT SHEET 1 OF 2

21044	MKS-MET-ZZ-ZZ-DR-E-6001A
drawn by: JM	checked by: EP
date: APR '22	scale: 1:200 @A0