


← FOR CONTINUATION AND TECHNICAL DATA SEE MKS-MET-ZZ-ZZ-DR-E-6001A



← FOR CONTINUATION AND TECHNICAL DATA SEE MKS-MET-ZZ-ZZ-DR-E-6001A

This drawing is the copyright of METEC Consulting Engineers and may not be reproduced in whole or in part without their expressed written permission. All figured dimensions are to be verified on site and any discrepancies to be reported to the Engineer immediately.

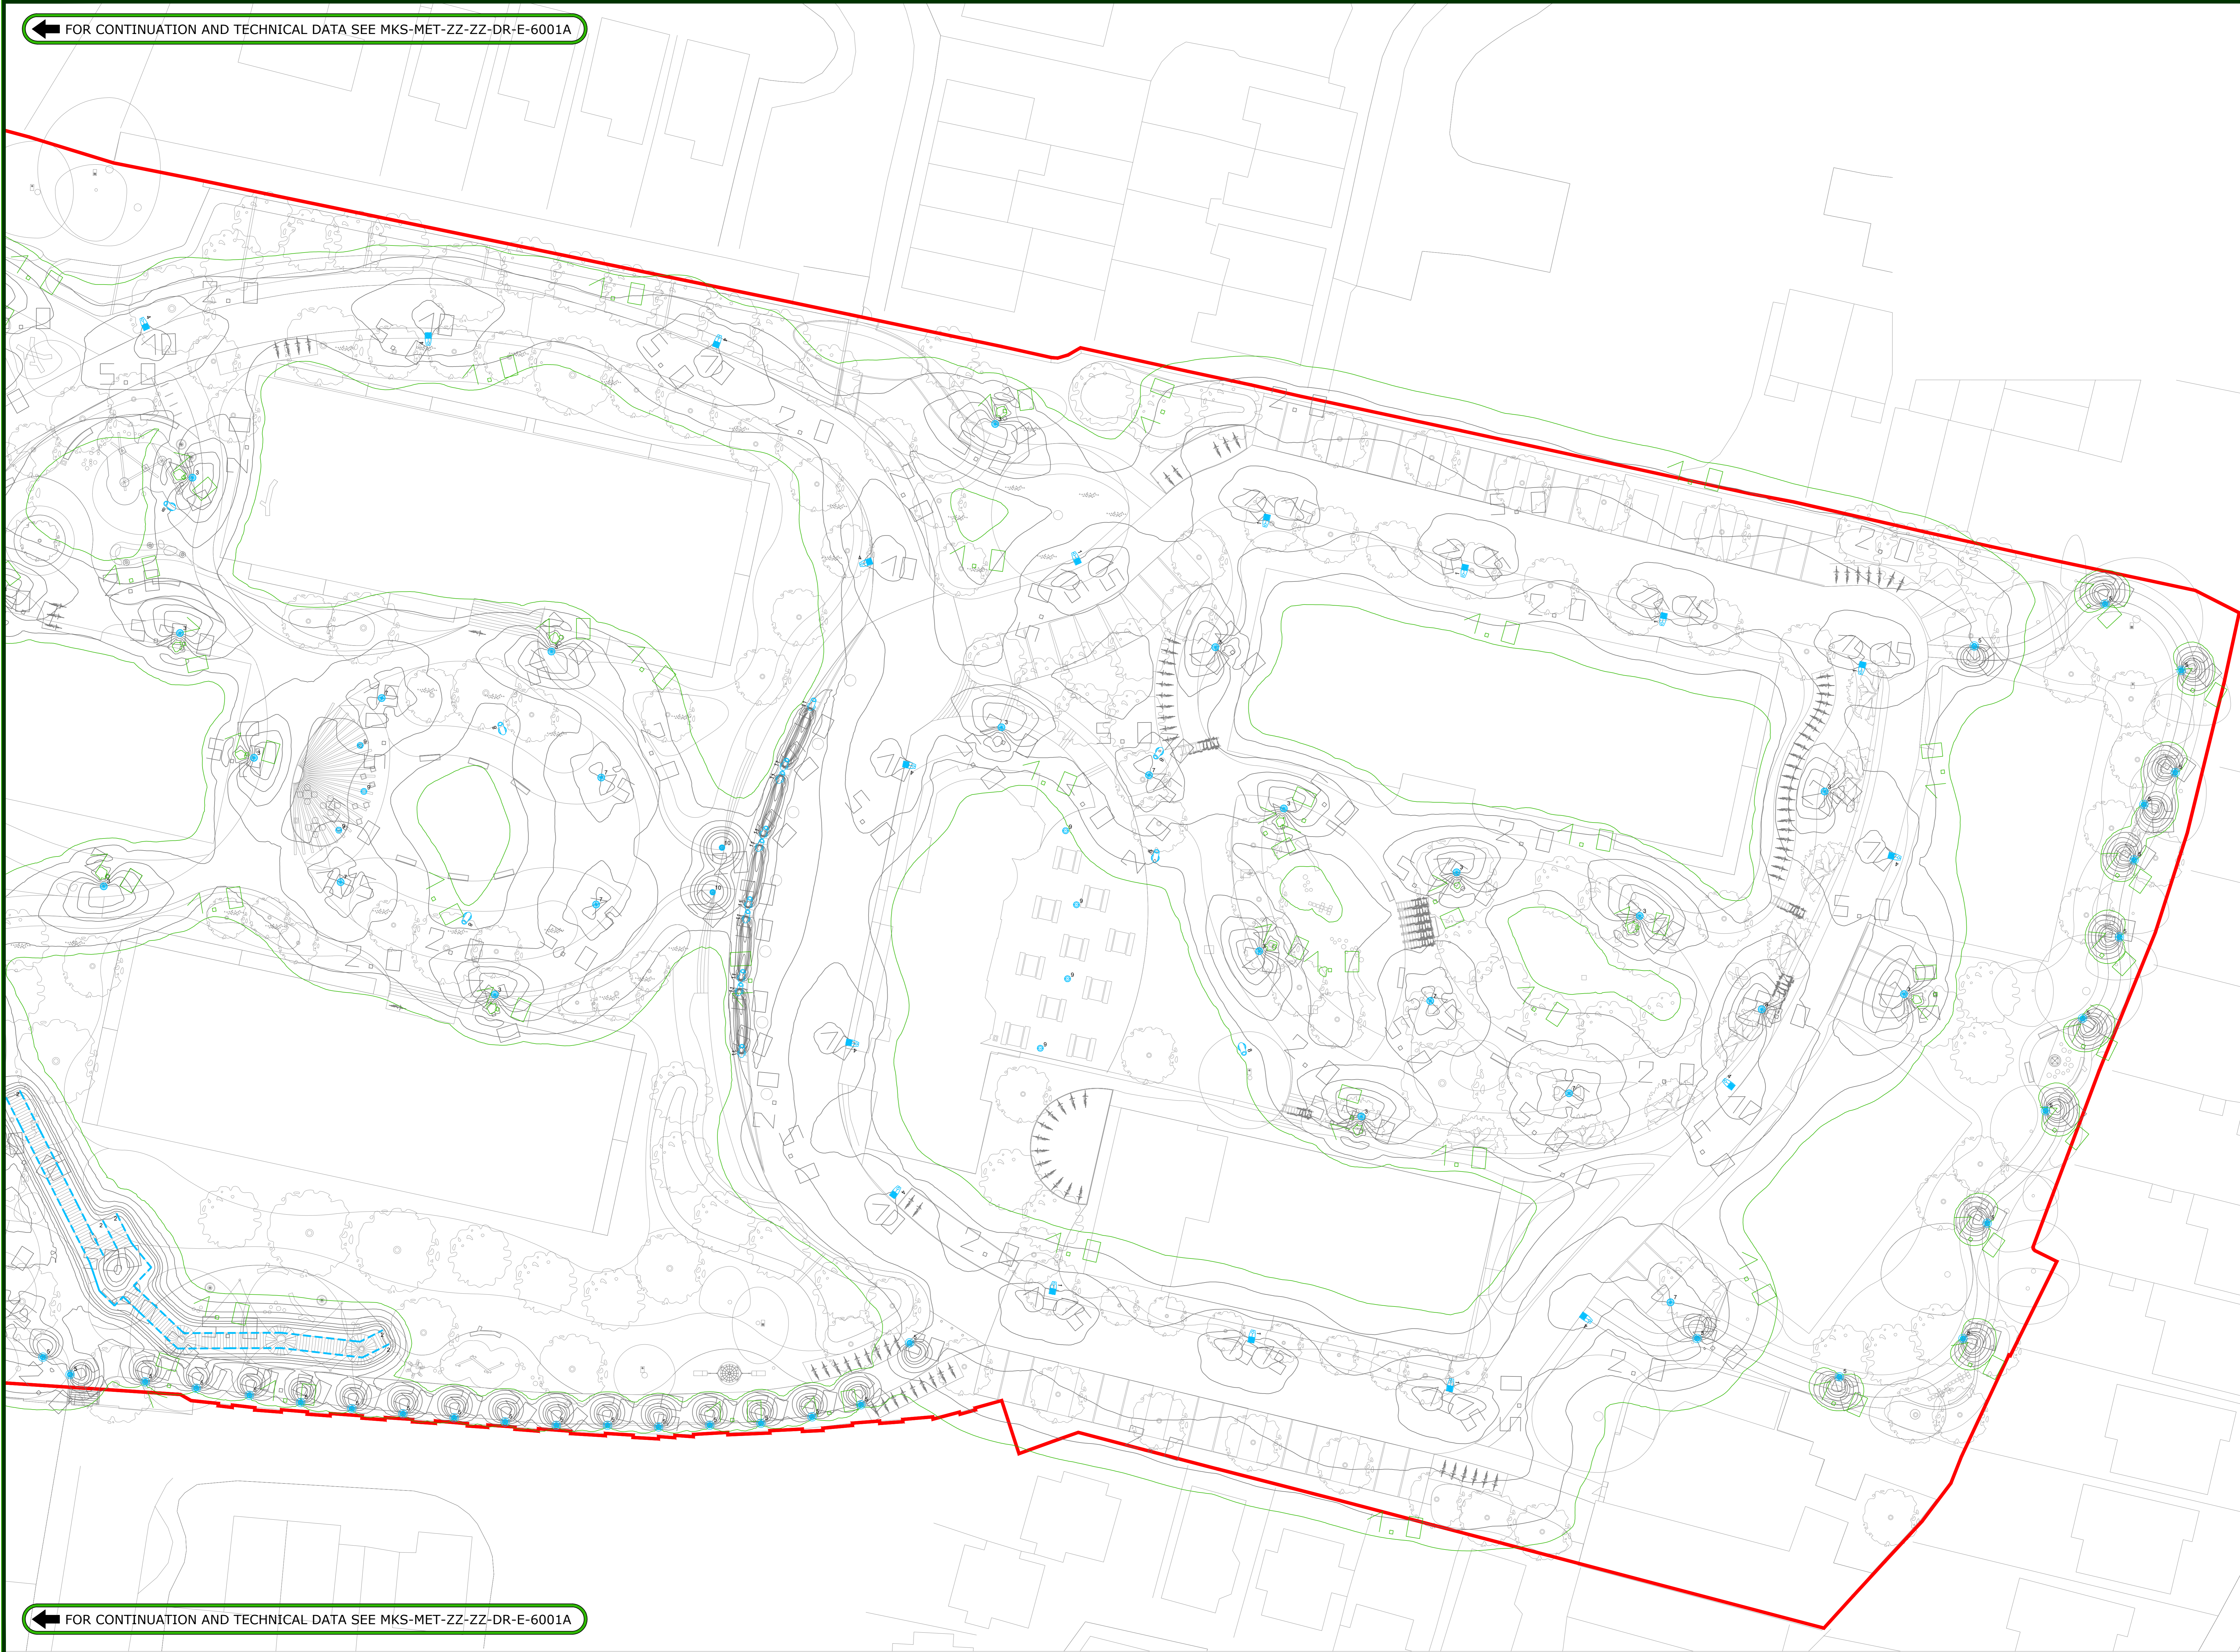

**LEGEND OF SYMBOLS**

- 1 TYPE 1 - KREOS SR/50 PERFORMANCE LIGHTING
  - 2 TYPE 2 - DUO LUNA (MOD/ADK/DC)
  - 3 TYPE 3 - HEDDHT SR/DT5 PERFORMANCE LIGHTING
  - 4 TYPE 4 - KREOS SR/100 PERFORMANCE LIGHTING
  - 5 TYPE 5 - INKY SUPER-COMFORT ILLUMIN
  - 6 TYPE 6 - WALKY SQUARE ILLUMIN
  - 7 TYPE 7 - HEDDHT PERFORMANCE LIGHTING
  - 8 TYPE 8 - PALCO IN/OUT ILLUMIN
  - 9 TYPE 9 - LIGHT UP EARTH ILLUMIN
  - 10 TYPE 10 - INKY SUPER-COMFORT ILLUMIN
  - 11 TYPE 11 - ATON P88 ALDABRA
- 1 LUX LIGHTING ISOLINES - INDICATES BOUNDARY LUX LEVELS

REV	DATE	DESCRIPTION
P01	OCT '22	PLANNING ISSUE



PROJECT: DALGUISE MONKSTOWN



**SITE LIGHTING LAYOUT SHEET 2 OF 2**

PROJECT NO: 21044	PROJECT: MKS-MET-ZZ-ZZ-DR-E-6001B
DRAWN BY: JM	CHECKED BY: EP
DATE: APR '22	SCALE: 1:200 @A0